


MCHENRY COUNTY COLLEGE

MCC SHAH CENTER SOLAR PHOTOVOLTAIC PV PROJECT

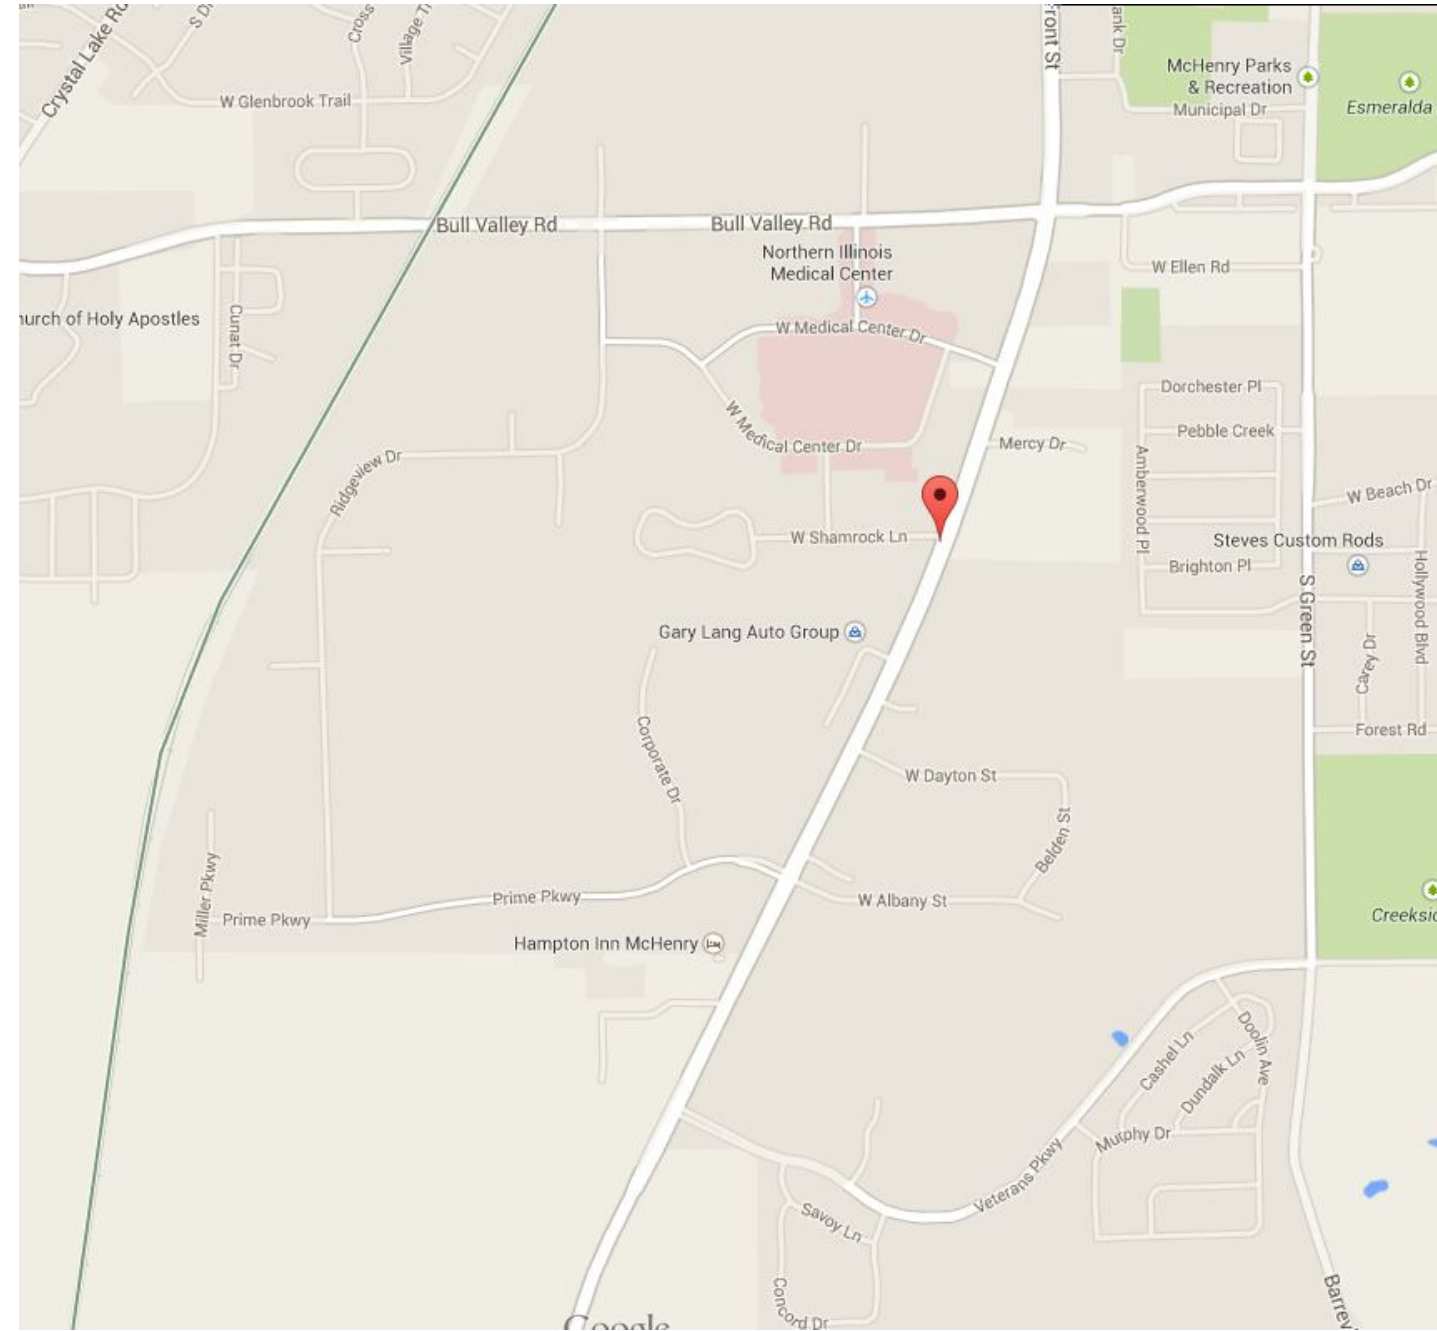

LOCATION MAP



AERIAL IMAGE

SHEET INDEX	
SHEET NUMBER	SHEET DESCRIPTION
C	COVER SHEET
S-1	PV ARRAY LOCATION
S-2	FOUNDATION PIER PLAN
S-3	SURFACE CONDITIONS PLAN
S-4	SECOND FLOOR PLAN / THIRD FLOOR PLAN
E-1	POWER DISTRIBUTION
E-2	MONITORING DIAGRAM



THIS IS TO CERTIFY THAT THESE DRAWINGS HAVE BEEN DONE UNDER MY DIRECT SUPERVISION AND TO THE BEST OF MY KNOWLEDGE COMPLY WITH ALL APPLICABLE ZONING AND BUILDING CODES